



**TYPICAL WALL SECTION**  
SCALE 3/4" = 1'-0"

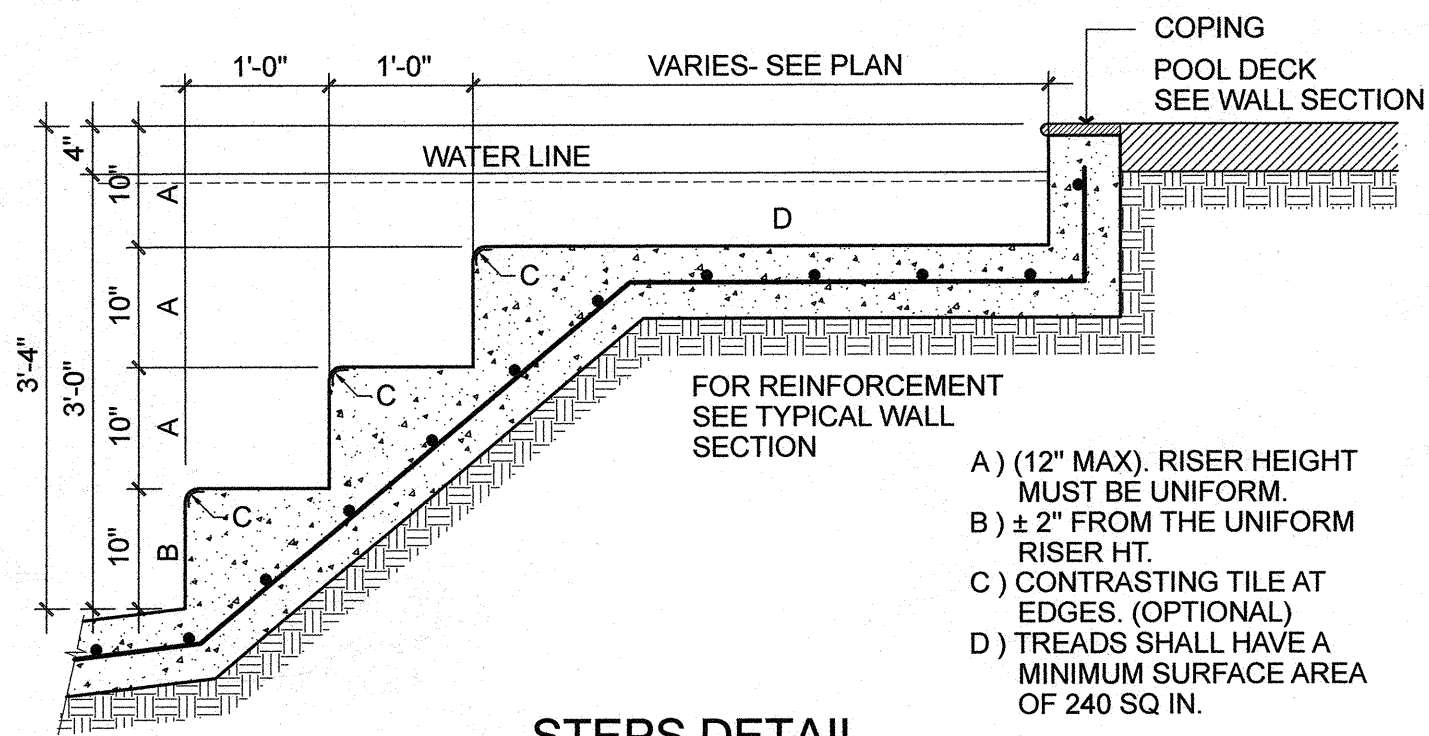


**STEPS DETAIL**  
SCALE 3/4" = 1'-0"


- A) (12" MAX.) RISER HEIGHT MUST BE UNIFORM.
- B) ± 2" FROM THE UNIFORM RISER HT.
- C) CONTRASTING TILE AT EDGES. (OPTIONAL)
- D) TREADS SHALL HAVE A MINIMUM SURFACE AREA OF 240 SQ. IN.

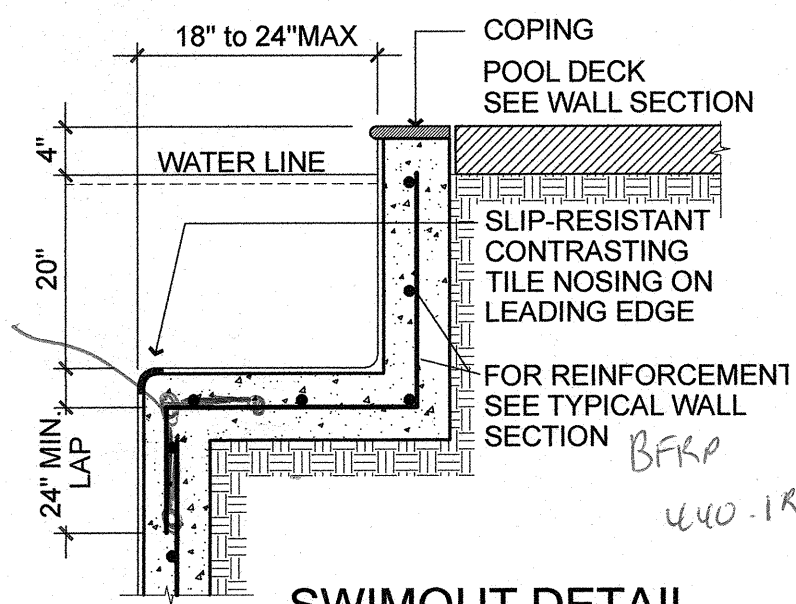

**SWIMOUT DETAIL**  
SCALE 3/4" = 1'-0"

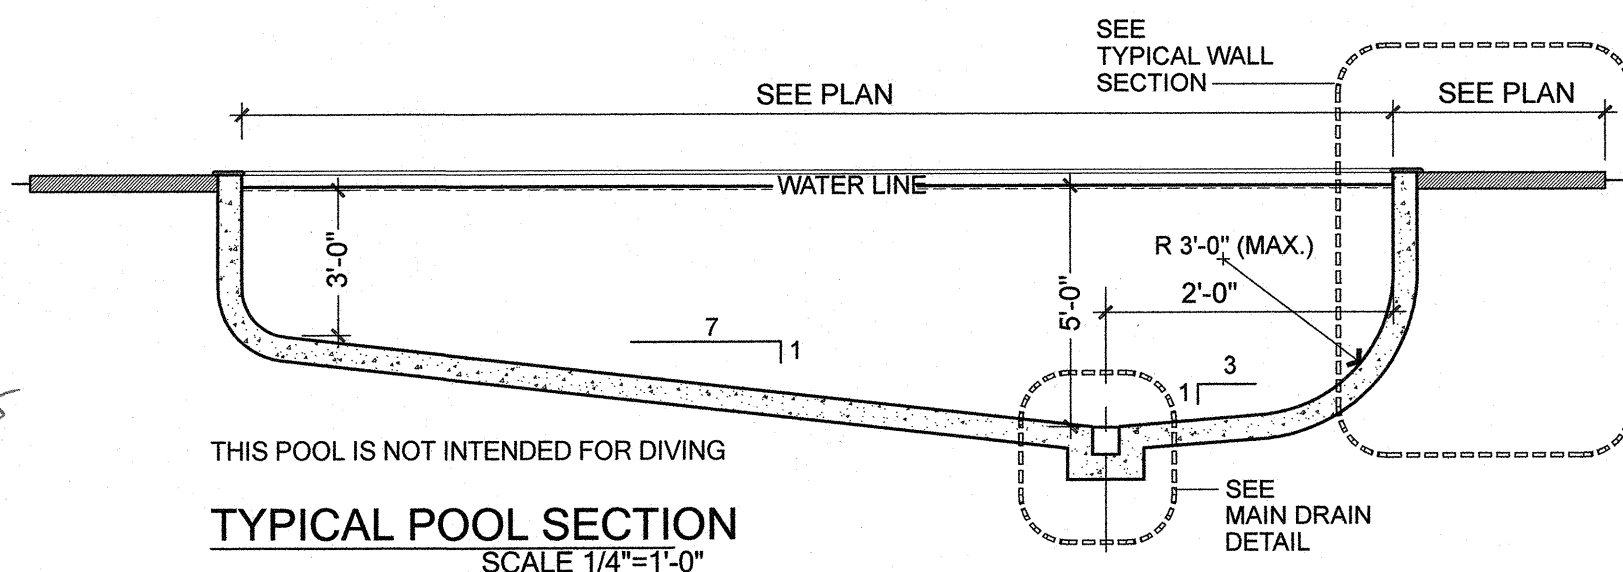

THIS POOL IS NOT INTENDED FOR DIVING  
**TYPICAL POOL SECTION**  
SCALE 1/4" = 1'-0"

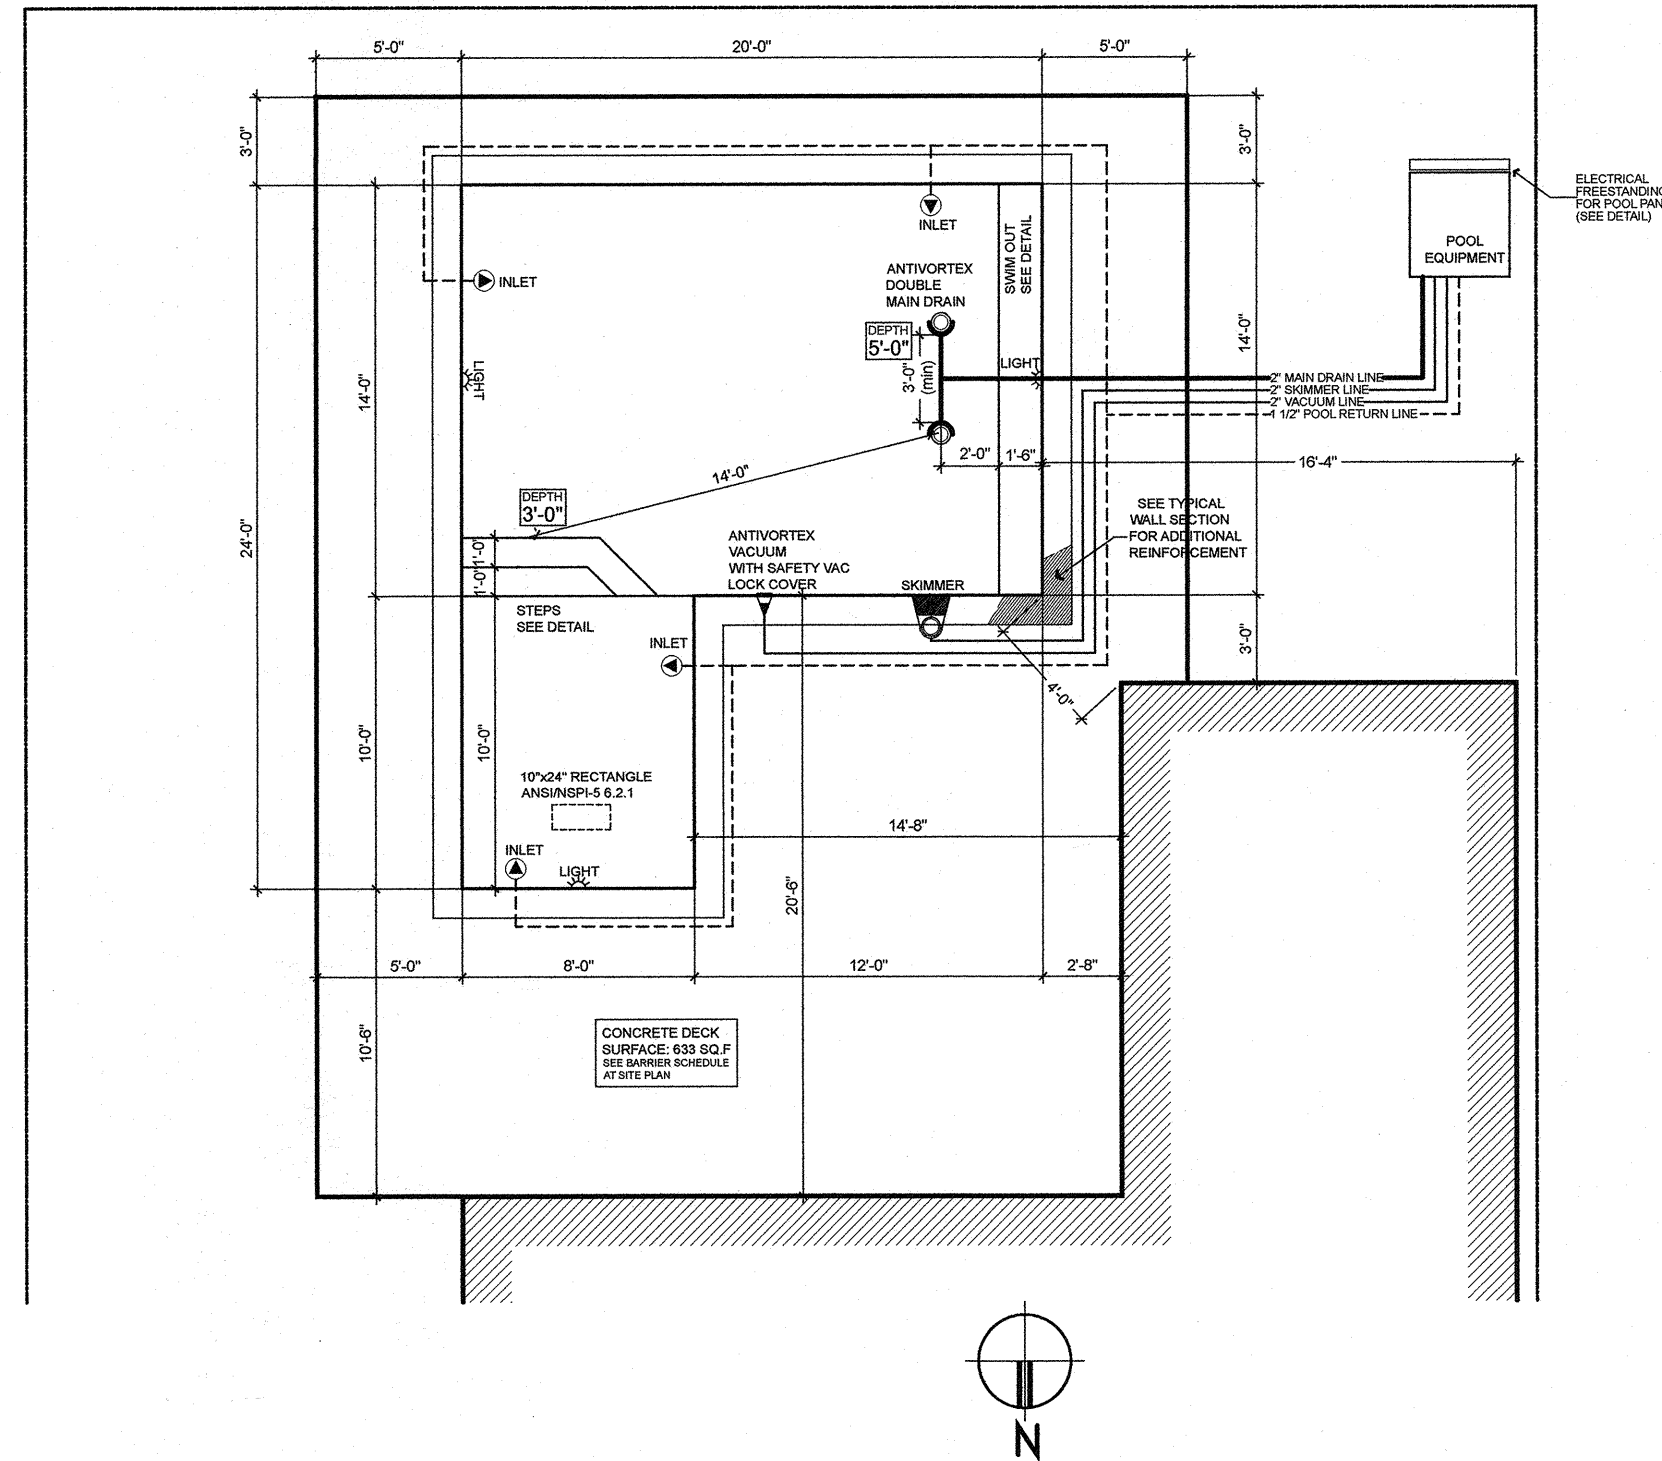

**POOL PIPING PLAN. scale 1/4"=1'**

REVISIONS

SIGN AND SEAL

STRUCTURAL DESIGN

TC ENGINEERING, INC. CA. LIC. NO. 30288  
CONSULTING ENGINEERS  
ANTONIO CANELAS, P.E. LIC. NO. 74699  
7815 SW 24 ST SUITE 111, MIAMI, FL 33155  
PHONE (305) 281-0321  
tcstructuraldesign@gmail.com

COMPANY NAME:  
**ROSAMEL POOLS & OUTDOORS**

PROJECT: **SWIMMING POOL PLAN**  
OWNER: **ILIANA GUTIERREZ RESIDENCE**  
ADDRESS: **13202 SW 39 TERRACE, MIAMI, FL**

DATE: **11-13-2017**  
SCALE: **AS NOTED**  
DESCRIPTION: **BLUE CAYMAN DESIGN**  
JOB No: **2017**  
REFERENCE:

DRAWING NO. **2 OF 3**